



VOLUME STUDIO

1700 RAVEY STREET
AUSTIN, TX 78746

T: 512.769.1724
F: 512.330.0616

AG@VOLUMESTUDIO.COM

CONSULTANTS:

NOT FOR CONSTRUCTION

THESE DRAWINGS, THE PROJECT MANUAL, AND THE DESIGN SHOWN THEREON ARE THE INSTRUMENTS OF SERVICE ONLY AND REMAIN THE PROPERTY OF VOLUME STUDIO INC. THE REPRODUCTION OR UNAUTHORIZED USE OF THESE DOCUMENTS WITHOUT WRITTEN CONSENT OF VOLUME STUDIO INC. IS PROHIBITED.

PEACOCK RESIDENCE

LONDON DOYLE
609 PEACOCK
AUSTIN, TX 78704


1ST FLR POWER & LTNG PLAN

DATE: 10/28/11
DRAWN BY: AMS
REVISED BY: AMS

A2.1

Scale 1/4" = 1'-0"

11/12/2011 4:35:33 PM

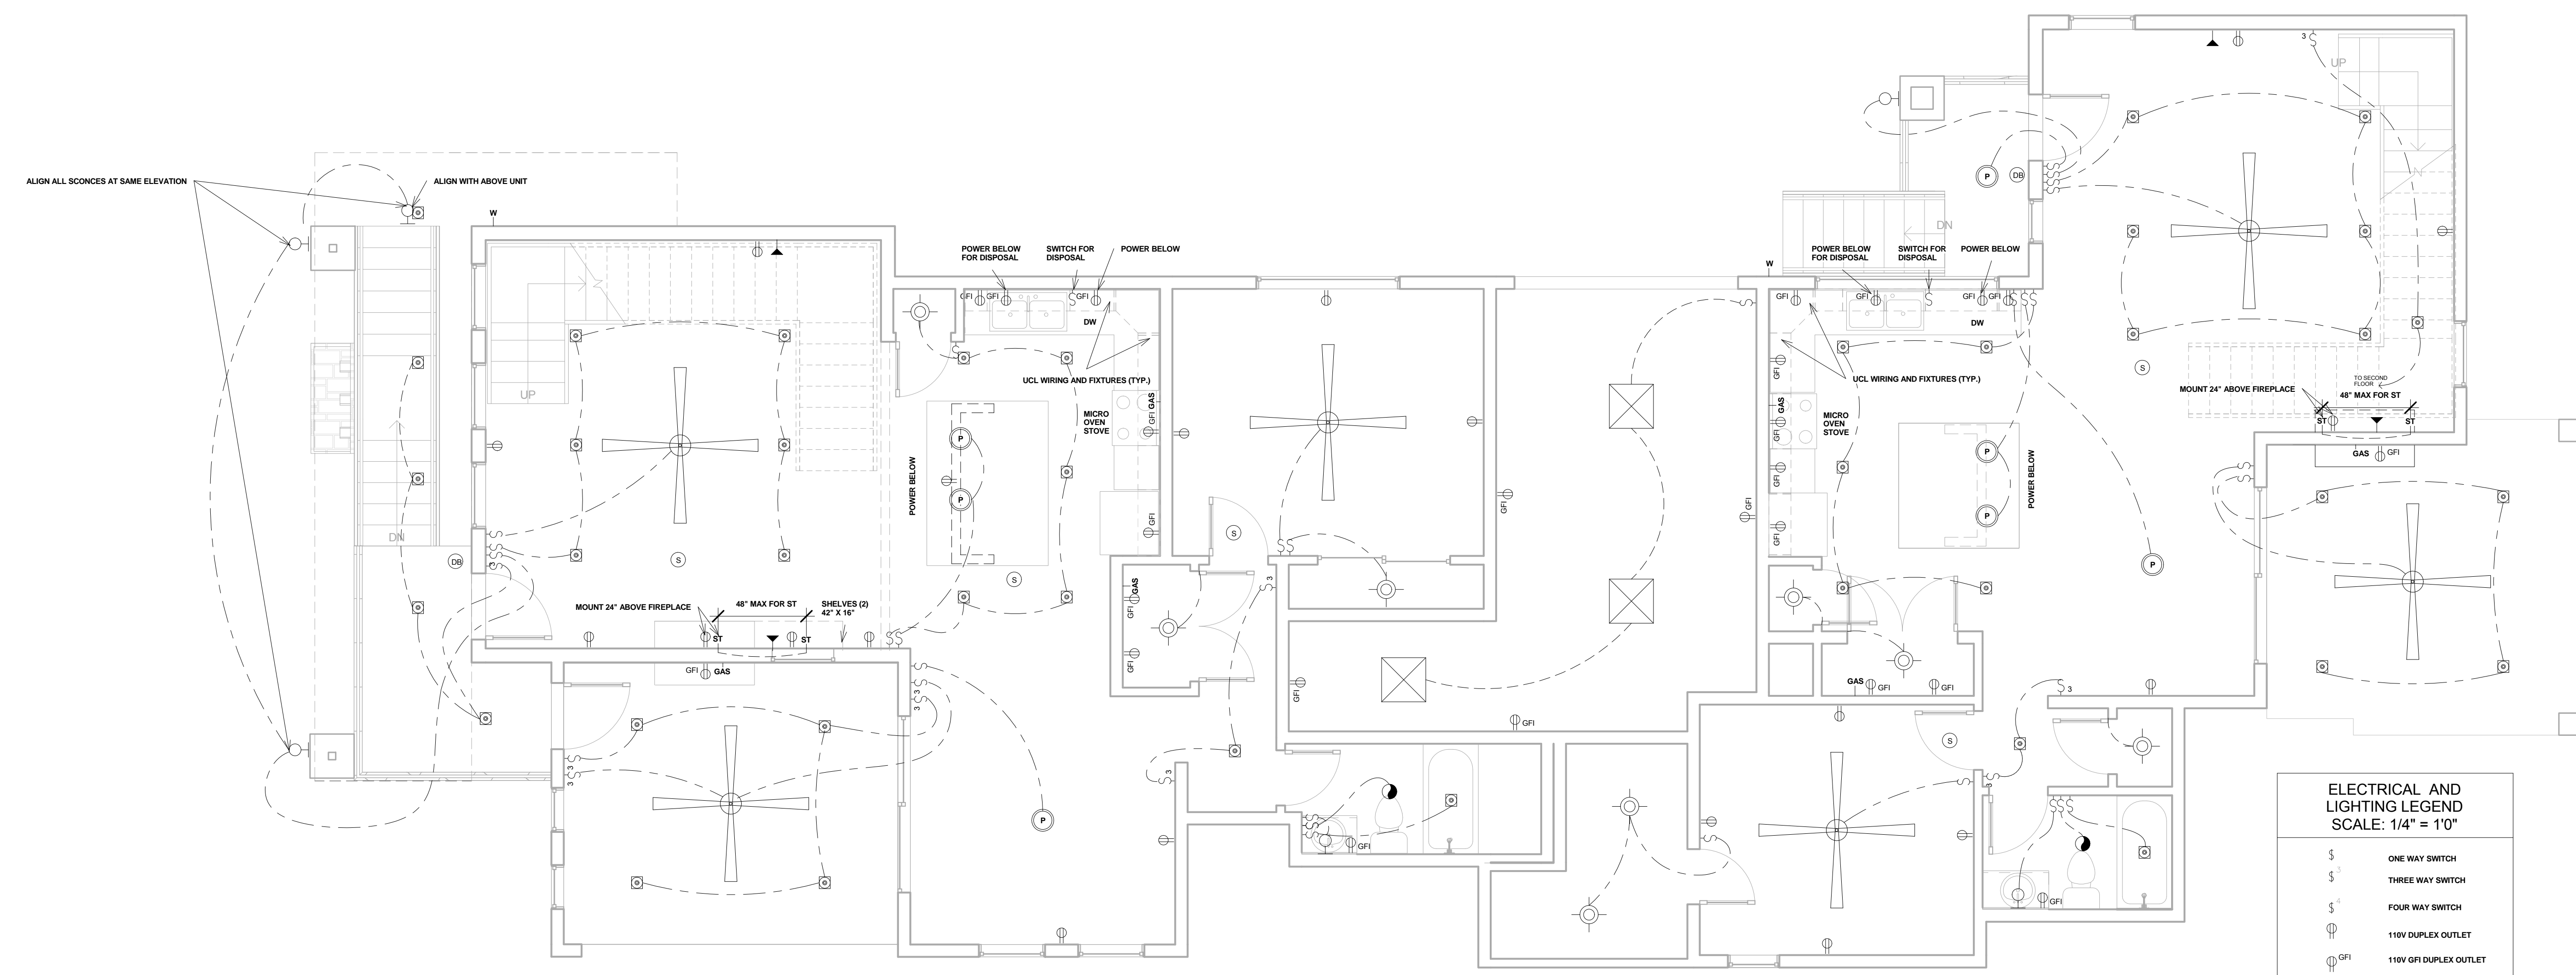

1 FIRST FLOOR ELECTRICAL PLAN
1/4" = 1'-0"

ELECTRICAL AND LIGHTING LEGEND
SCALE: 1/4" = 10"

\$	ONE WAY SWITCH
\$ ³	THREE WAY SWITCH
\$ ⁴	FOUR WAY SWITCH
⊕	110V DUPLEX OUTLET
⊕ GFI	110V GFI DUPLEX OUTLET
▲	DATA
▲	SMURF TUBE
GAS	GAS
W	WATER
S	SMOKE DETECTOR
DB	DOOR BELL
⊕	6" RECESSED CAN
⊕ WP	6" WATERPROOF
⊕	WALL MOUNTED FIXTURE
⊕	PENDANT-ALIGN WITH MILLWORK BELOW IF REQ.
⊕	SURFACE MOUNTED FIXTURE
—	TRACK LIGHTING
●	EXHAUST FAN
⊗	2 x 2 FLOURESCENT
⊗	FANLIGHT COMBO